

127

BEDROOM

100

STOR

DIAG. NO. REVISION DATE  
A-1 02-25-8

12A21

\_\_\_\_\_

\_\_\_\_\_

\_\_\_\_\_

\_\_\_\_\_

\_\_\_\_\_

\_\_\_\_\_

\_\_\_\_\_

\_\_\_\_\_

12A11  
206sf

\_\_\_\_\_

206sf

12c11

\_\_\_\_\_

220sf

12c21

\_\_\_\_\_

\_\_\_\_\_

\_\_\_\_\_

\_\_\_\_\_

\_\_\_\_\_

\_\_\_\_\_

\_\_\_\_\_

DWG. NO.:  
**A-2**

REVISION DATE:  
08-22-2018

SCALE:

DESIGN BY:

BLDG. CODE: 1 - - - - PLANTING & GROUNDWORK

13C1

13B5

13S1



13D1

13C31

13C5

13D51

● Water Bottle Refill Station

● Standard Water Fountain

DWG. NO: **A-3**  
REVISION DATE: 08-22-2018  
SCALE:  
DESIGN BY: PLA  
BLDG. CODE: CK  
CHECKED BY: JCD

RECORD FLOOR PLAN  
CHOPTANK HALL BUILDING

THIRD FLOOR PLAN

**SALISBURY UNIVERSITY**  
FACILITIES PLANNING & CAPITAL PROJECTS  
ARCHITECTURAL AND ENGINEERING SERVICES  
1101 CAMDEN AVENUE  
SALISBURY, MARYLAND 21801  
410-543-6215

4B2

4A1

4B1

4C1

4D1

4E1

4C4

4C5

4D5



4C2

DWG. NO.: **A-4**  
 REVISION DATE: 08-22-2018  
 SCALE:  $\frac{1}{8}"=1'$   
 DESIGN BY: PLA  
 BLDG. CODE: CK  
 CHECKED BY: JCD

RECORD FLOOR PLAN  
 CHOPTANK HALL BUILDING

FOURTH FLOOR PLAN

**SALISBURY UNIVERSITY**  
 FACILITIES PLANNING & CAPITAL PROJECTS  
 ARCHITECTURE AND ENGINEERING SERVICES  
 1101 CAMDEN AVENUE  
 SALISBURY, MARYLAND 21801  
 410-543-6215

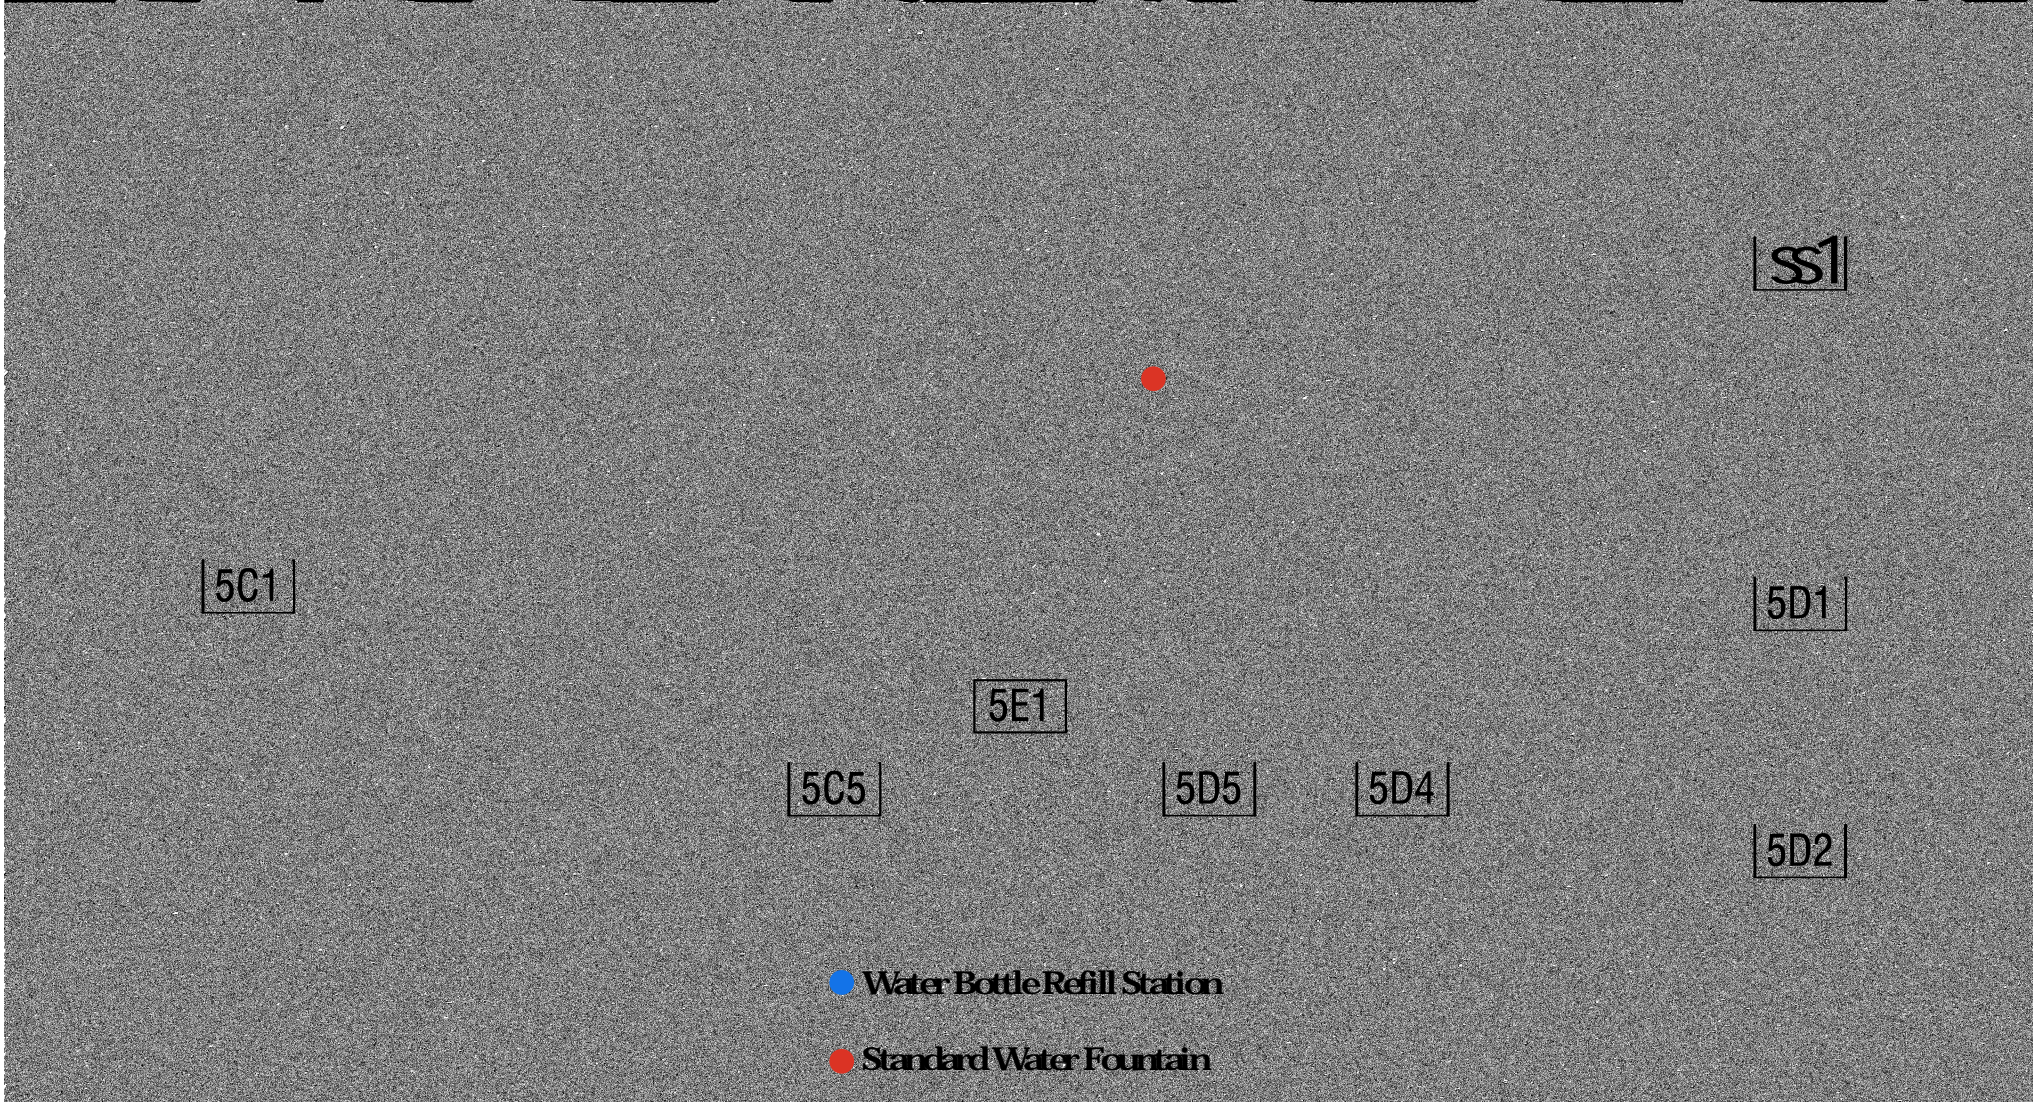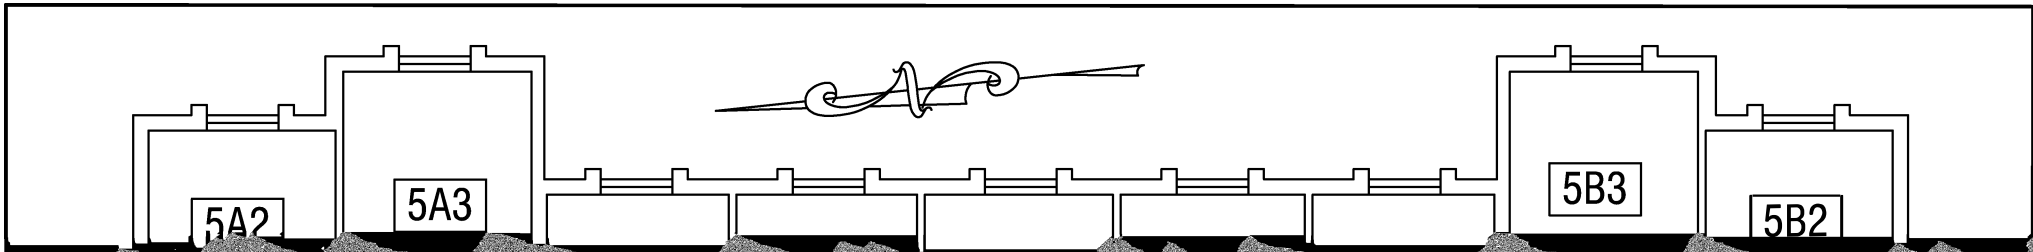

- Water Bottle Refill Station
- Standard Water Fountain

DIAG. NO: **A-5**  
 REVISION DATE: 08-22-2013  
 SCALE:  
 DESIGN BY:  
 BLDG. CODE: **CK**  
 CHECKED BY: **JCD**

" z " %flz z " %l Z %  
 / z ! # % flfl% \$ fl flz ! %

fl # / %flz z " %l Z %

**SALISBURY UNIVERSITY**  
 FACILITIES PLANNING & CAPITAL PROJECTS  
 ARCHITECTURAL AND ENGINEERING SERVICES  
 1101 CAMDEN AVENUE  
 SALISBURY, MARYLAND 21801  
 410-543-6215

16B31

16

6E1

16C5

16D51

16D41

DWG. NO.: **A-6**  
REVISION DATE: **08-22-2018**  
SCALE: **1"=1'**  
DESIGN BY: **PLA**  
BLDG. CODE: **CK**  
CHECKED BY: **JCD**

RECORD FLOOR PLAN  
CHOPTA HALL BUILDING

SIXTH FLOOR PLAN